
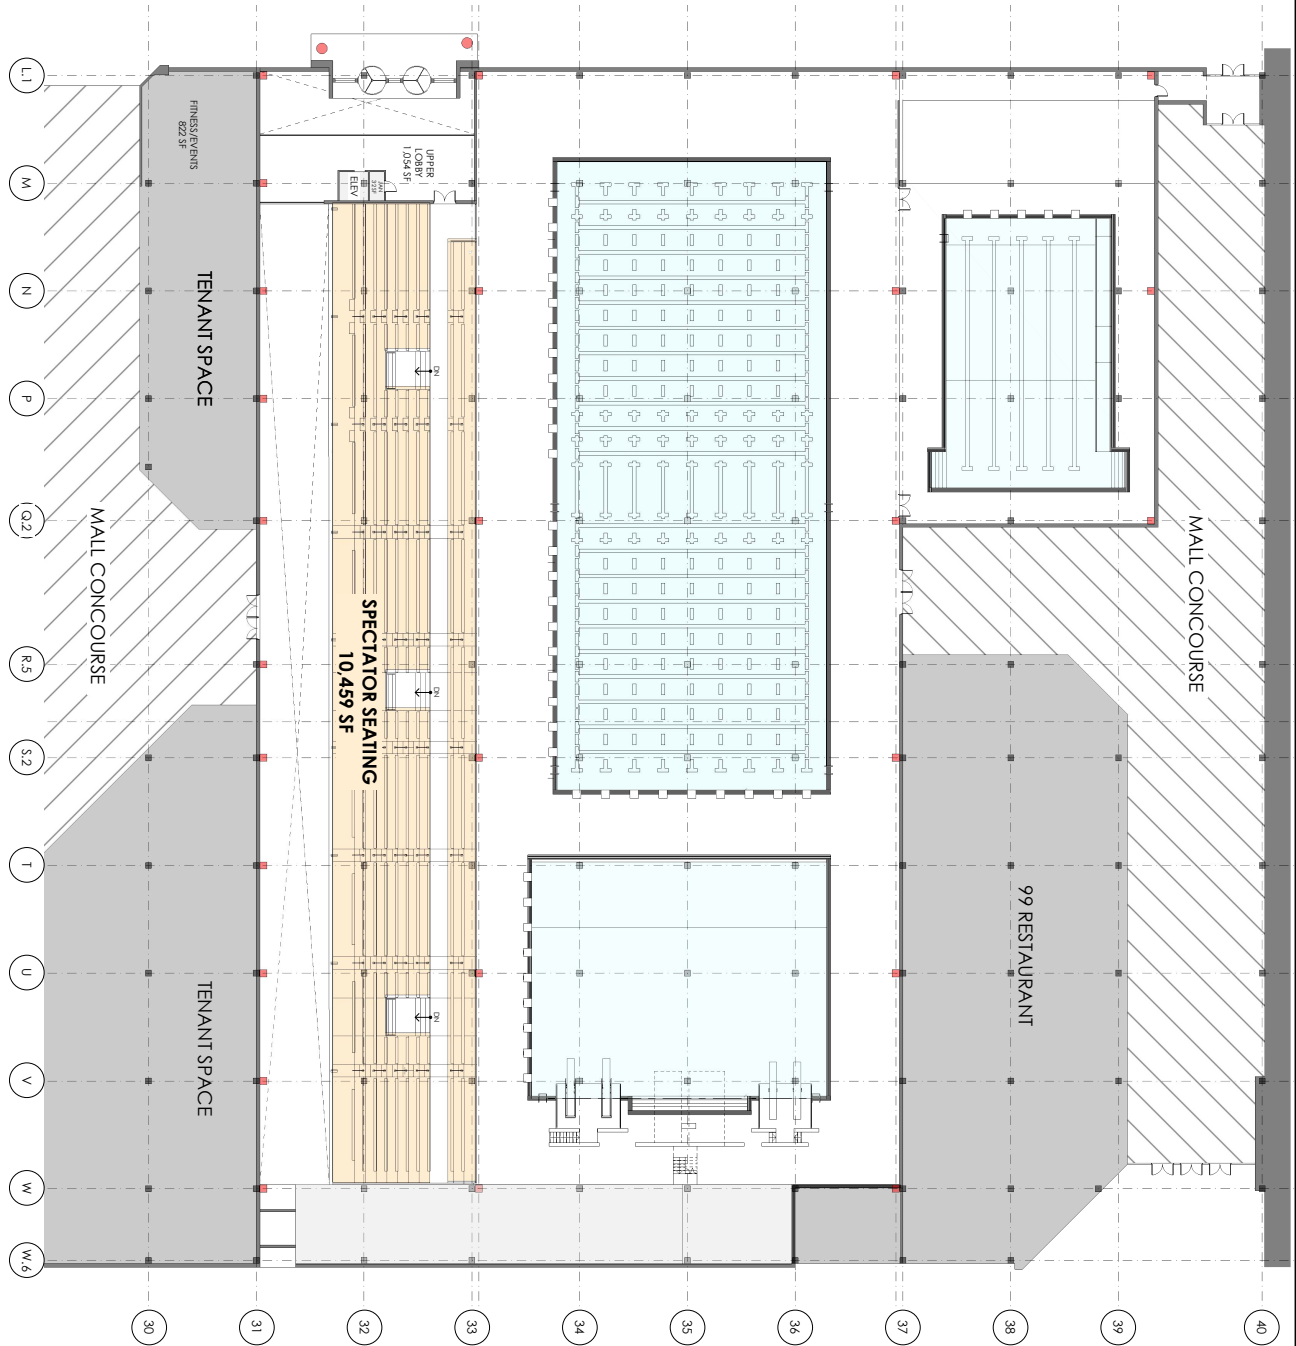


FUNCTION	PROGRAM SF	PLAN	
		L1	L2
POOL & SPA MECHANICAL ROOM	2,476	2,385	
LOCKER ROOM - WOMEN	812	773	
LOCKER ROOM - MEN	769	773	
OFFICE	465	203	
FRONT DESK	265	170	
CONTROL	186	105	
LIFEGUARD STATION	245	174	
STAFF ADMIN	1,094	1,057	
LOCKER ROOMS - TEAM	2,915	3,129	
TOILET ROOM	2,356	1,954	
JANITOR'S CLOSET	162	149	
STORAGE	942		
HOSPITALITY	1,095	1,149	
ADMIN/OFFICIALS	1,014	1,106	
WEB PRODUCTION	505	575	
VIDEO REVIEW	546	575	
POOL, INSTRUCTION DECK	1,089	3,062	
POOL, COMPETITION DECK	18,209	17,568	
LOADING DOCK	632	600	
LOBBY	1,359	1,370	1,067
SPECTATOR CONCOURSE	4,860	4,643	
SPECTATOR SEATING	7,316		10,459
INSTITUTIONAL POOL	3,600	3,530	
COMPETITION POOL	13,125	13,125	
DIVE WELL	5,412	5,412	
STAIRS	483	555	
ELEVATOR	200	100	100
CORRIDOR	548	1,686	
	72,680	65,928	11,626
		77,554	

	AAC OPERATIONS
	OFFICIALS / HOSPITALITY
	ADN MEDIA
	SPECTATORS / PUBLIC
	REST ROOMS
	LOCKERS / SHOWERS
	TOILETS / CHANGING
	POOLS
	BUILDING / POOLS SERVICES & UTILITIES

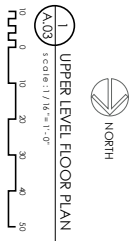

SHEET TITLE
UPPER LEVEL FLOOR PLAN

PROJECT NO.
00000
PROGRESS DATE
03 | 14 | 2023
DRAWN BY
SRL

PROJECT
PROPOSED AQUATIC CENTER
ROTTERDAM SQUARE
93 WEST CAMPBELL ROAD
SCHENECTADY NY 12306

CLIENT
SCHENECTADY AQUATIC CENTER



SCALE AS SHOWN
A.03