



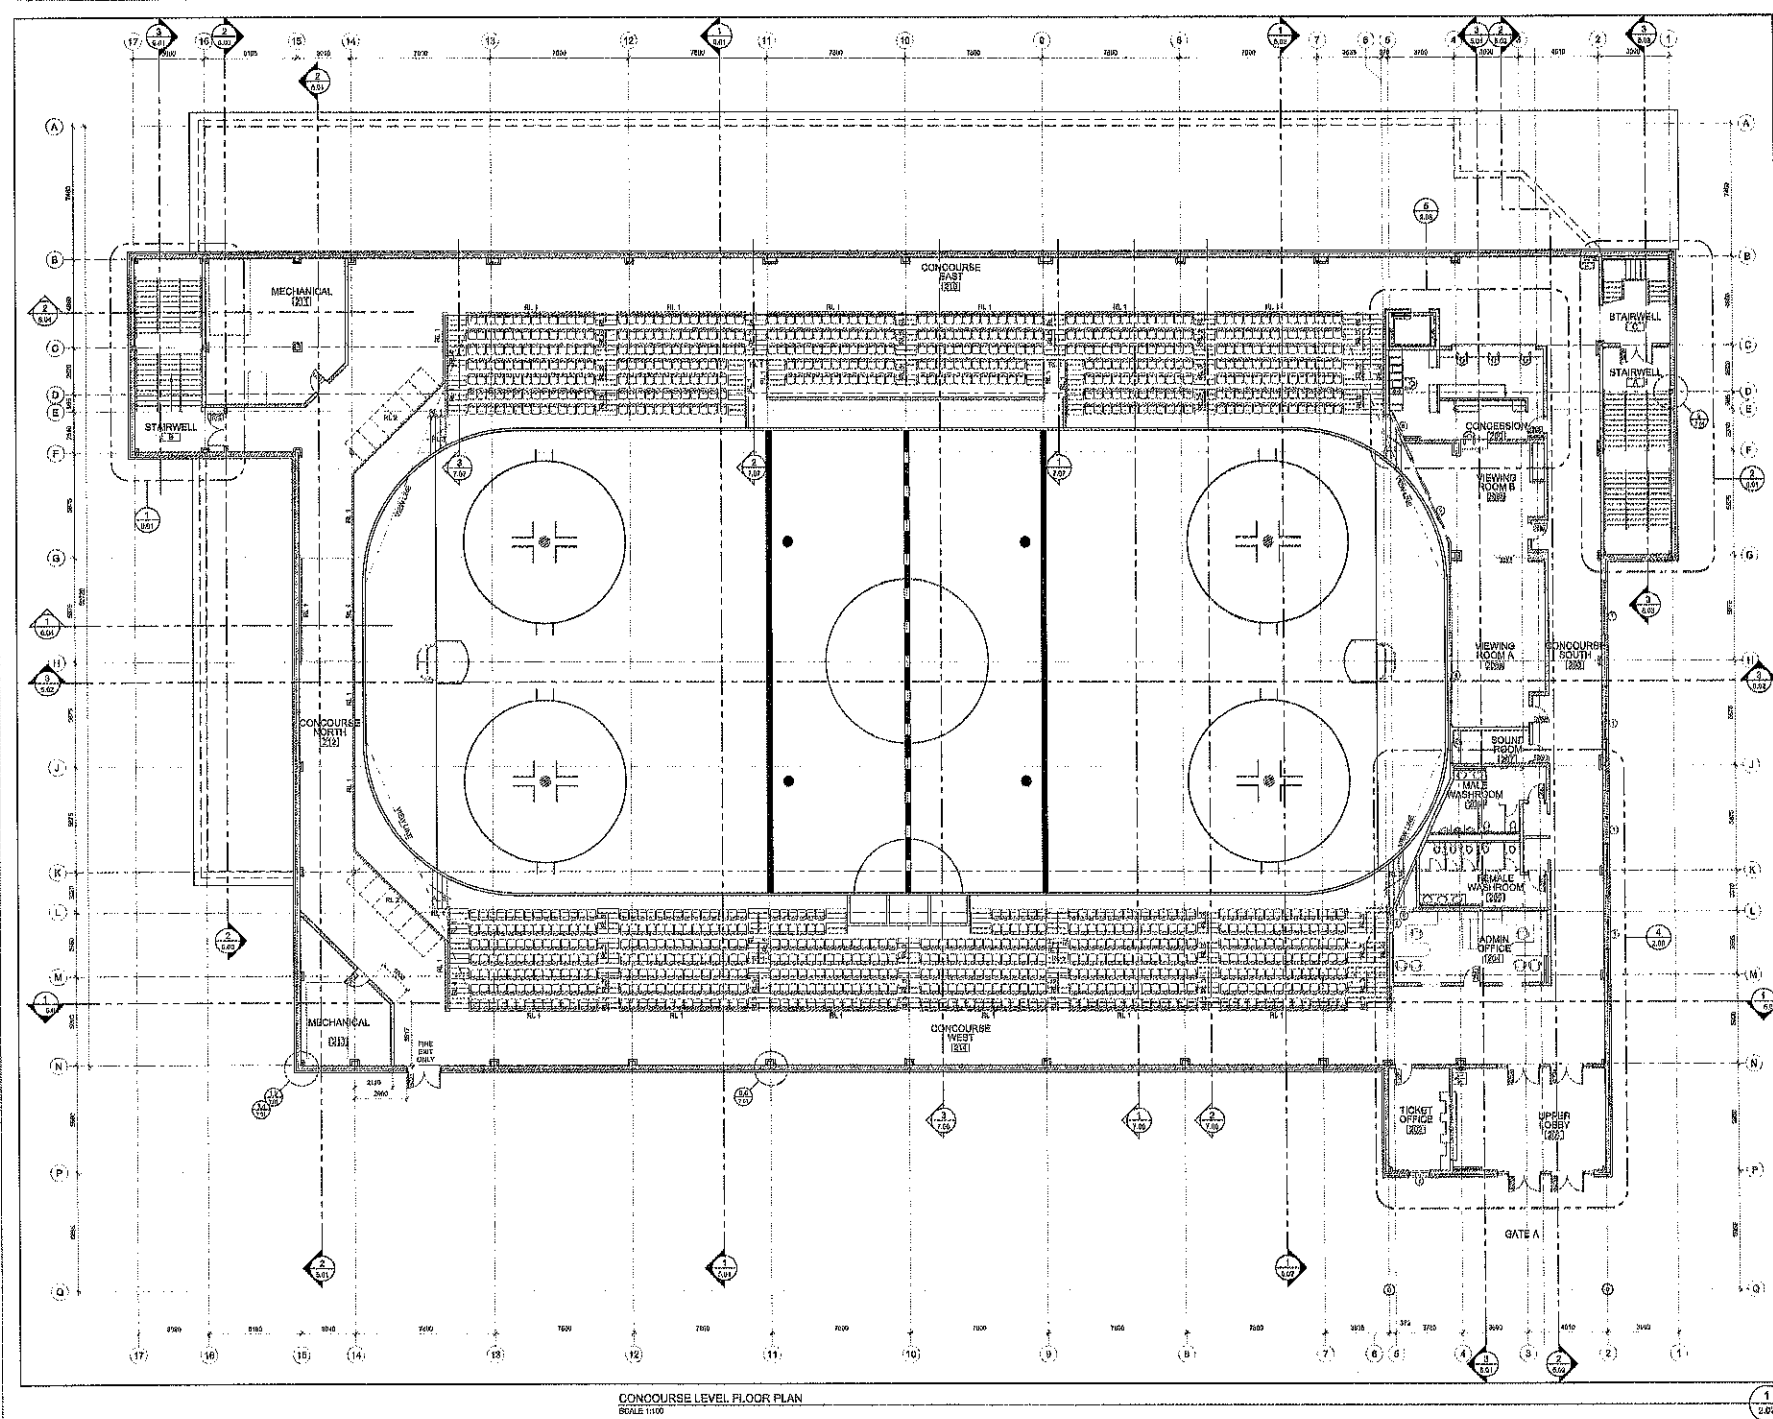

**Newfoundland
Labrador**
Department of Municipal Affairs
Government of Newfoundland and Labrador

CONCEPTUAL DESIGN: THESE ARE PRELIMINARY AND NOT TO BE USED FOR CONSTRUCTION. ANY CHANGES TO THE DESIGN SHALL BE MADE BY THE DESIGNER. THE DESIGNER SHALL BE RESPONSIBLE FOR THE DESIGN AND SHALL BE RESPONSIBLE FOR THE DESIGN. THE DESIGNER SHALL BE RESPONSIBLE FOR THE DESIGN.

RL 1 RAIL TYPE 1
RL 2 RAIL TYPE 2
RL 3 RAIL TYPE 3
RL 4 RAIL TYPE 4

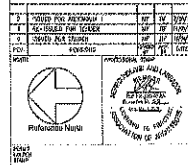

**HEARN FOUNGERE
ARCHITECTS INC.**
ARCHITECTS
1000 BAYVIEW AVE. SUITE 100
SCARBOROUGH, ONTARIO M1S 5B9
TEL: (416) 291-1100
WWW.HFARCHITECTS.COM

**CORECO
ENGINEERING INC.**
MECHANICAL & ELECTRICAL CONSULTANTS
1000 BAYVIEW AVE. SUITE 100
SCARBOROUGH, ONTARIO M1S 5B9
TEL: (416) 291-1100
WWW.CORECOENGINEERING.COM

**BAE + NEWPLAN
GROUP**
BAE + NEWPLAN GROUP LIMITED
1100 TOWNHALL RD. SUITE 100, A1111
ST. JOHN'S, NL A1B 1X1
TEL: (709) 463-1100
WWW.BAE-NEWPLAN.COM

**TOWN OF
CONCEPTION
BAY SOUTH**

**C.B.S. STADIUM
BUILDING PACKAGE
CP-4**

**CONCOURSE LEVEL
FLOOR PLAN**

DATE	BY	REVISED	BY	DATE
12/04/20	12/04/20	12/04/20	12/04/20	12/04/20
12/04/20	12/04/20	12/04/20	12/04/20	12/04/20
12/04/20	12/04/20	12/04/20	12/04/20	12/04/20

DATE: 12/04/20
DWG NO: 04 01 AR
SCALE: 1:100
SHEET NO: 2 OF 2